


SANITARY SEWER INTERCEPTOR PLAN VIEW
SCALE: 1" = 30'

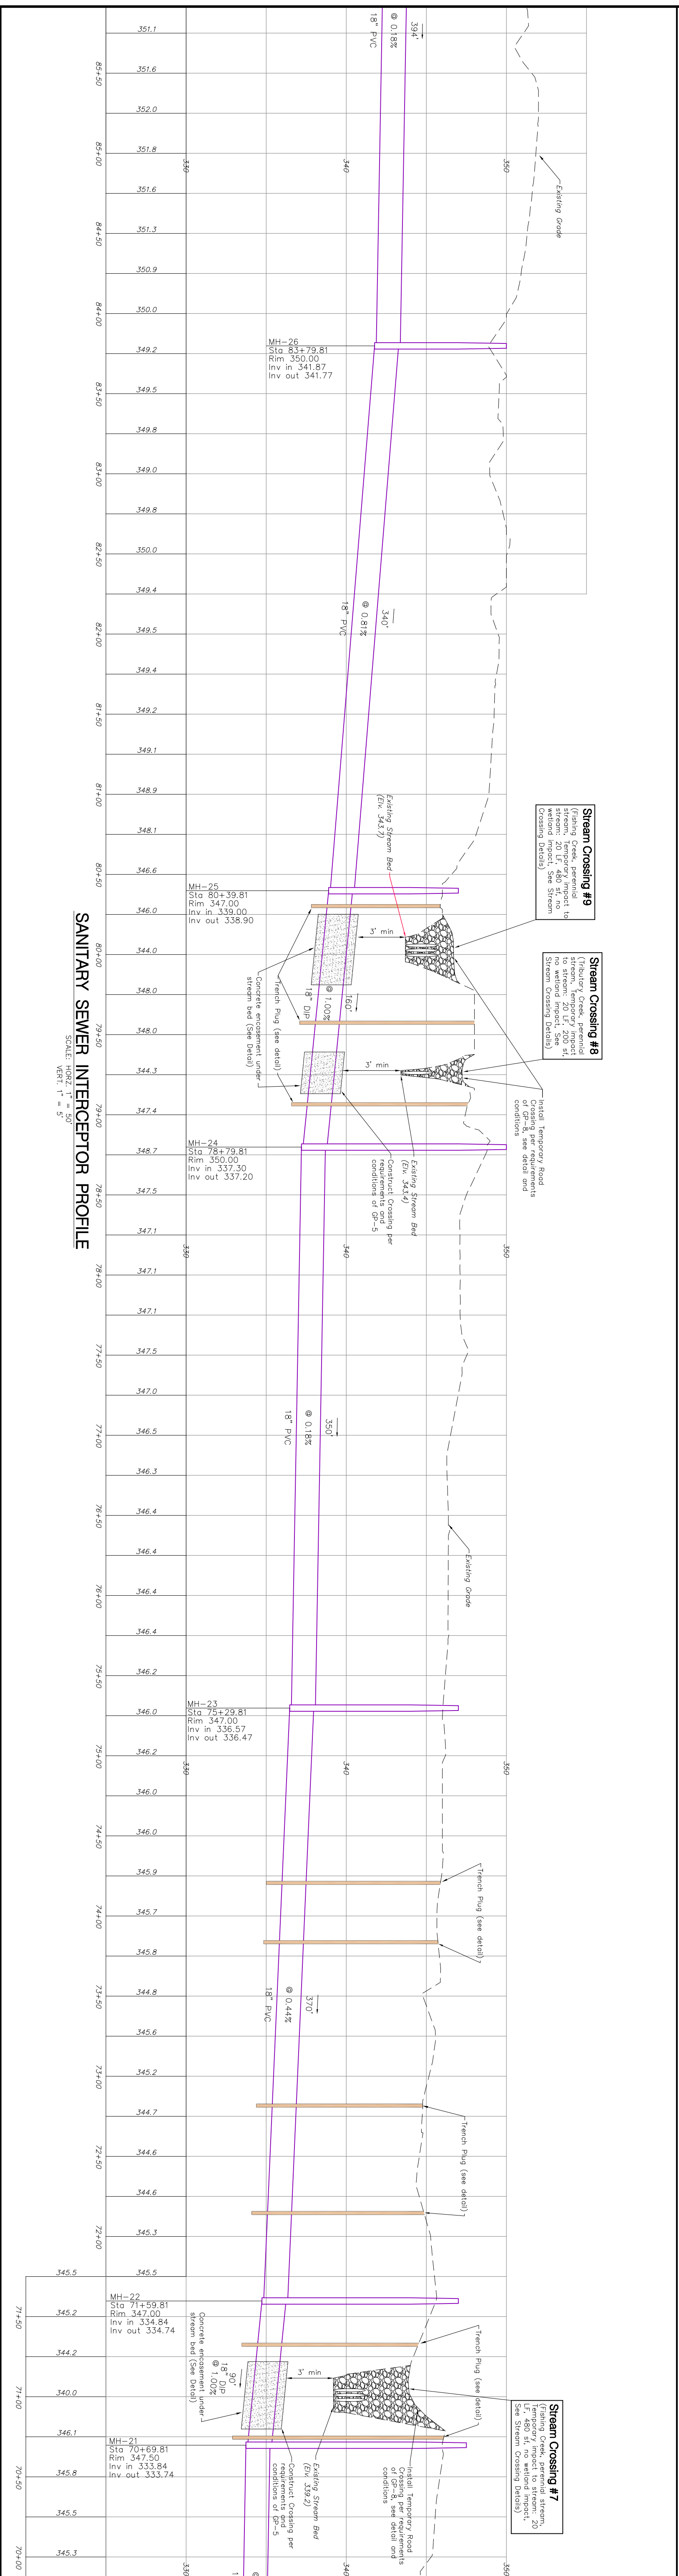


Erosion and Sediment Control Plan

9 of 14

Project No. 207041
Date: November 15, 2007

SANITARY SEWER PLAN AND PROFILE
FOR
WHITE OAK SEWER INTERCEPTOR
Located In
NEWBERRY TOWNSHIP, YORK COUNTY, PENNSYLVANIA

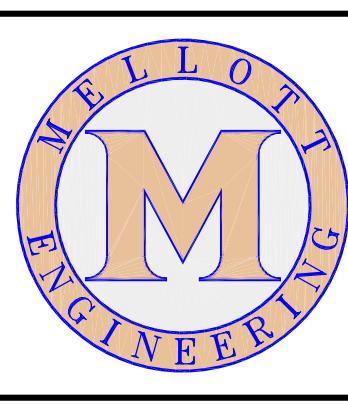

MELLOTT ENGINEERING, INC.
Civil Engineering • Land Planning & Development • Water Resources
7500 Devonshire Heights Road • Hummelstown, PA 17036
mellotteng@comcast.net
717-566-6533

REVISIONS	DATE
1. Authority Review Comments & E&S Detailing	12-11-07
2. Finalized Plan for first E&S Plan Submission	2-20-08
3. Sewer Alignment Revisions (MH-29 to MH-32)	5-1-08
4. Ebersole Property (easement shift & detailed notes)	5-2-08
5. Revised alignment (PHMC Area and Army Corp Easement)	7-22-08
6. Erosion Control Plan Revisions & Drafting	7-25-08
7. Erosion Control Plan Revisions	8-6-08
8.	
9.	